

COVER

DRAWINGS

- A1 - ENTRY FLOOR PLAN
- A2 - ENTRY ELEVATION
- A3 - CEILING PLAN
- A4 - HANOVER STREET ELEVATION
- A5 - CORNER ELEVATION
- A6 - MARKET STREET ELEVATION
- A6 - CORNER PERSPECTIVE

SPEC SHEET ATTACHMENTS:

- S1 - CR LAURENCE CUT SHEETS
- S2 - SWENSON GRANITE CUT SHEETS
- S3 - ALUCOBOND CLADDING CUT SHEETS



**SPRINGER'S JEWELERS PORTSMOUTH
EXTERIOR RENOVATIONS**

100 MARKET STREET, PORTSMOUTH, NH

HDC APPLICATION

DECEMBER 16, 2020

CANAL 5 STUDIO
Architecture / Planning / Interior Design


207 553 2115
One Canal Plaza, Suite 888
Portland, Maine 04101

canal5studio.com

THIS DRAWING IS THE PROPERTY OF CANAL 5 STUDIO AND IS NOT TO BE COPIED OR REPRODUCED IN PART OR WHOLE.
2020 © CANAL 5 STUDIO




GRANITE: WOODBURY GRAY.
2" THICK., 16" X 36" (SEE INCLUDED SPEC SHEET)

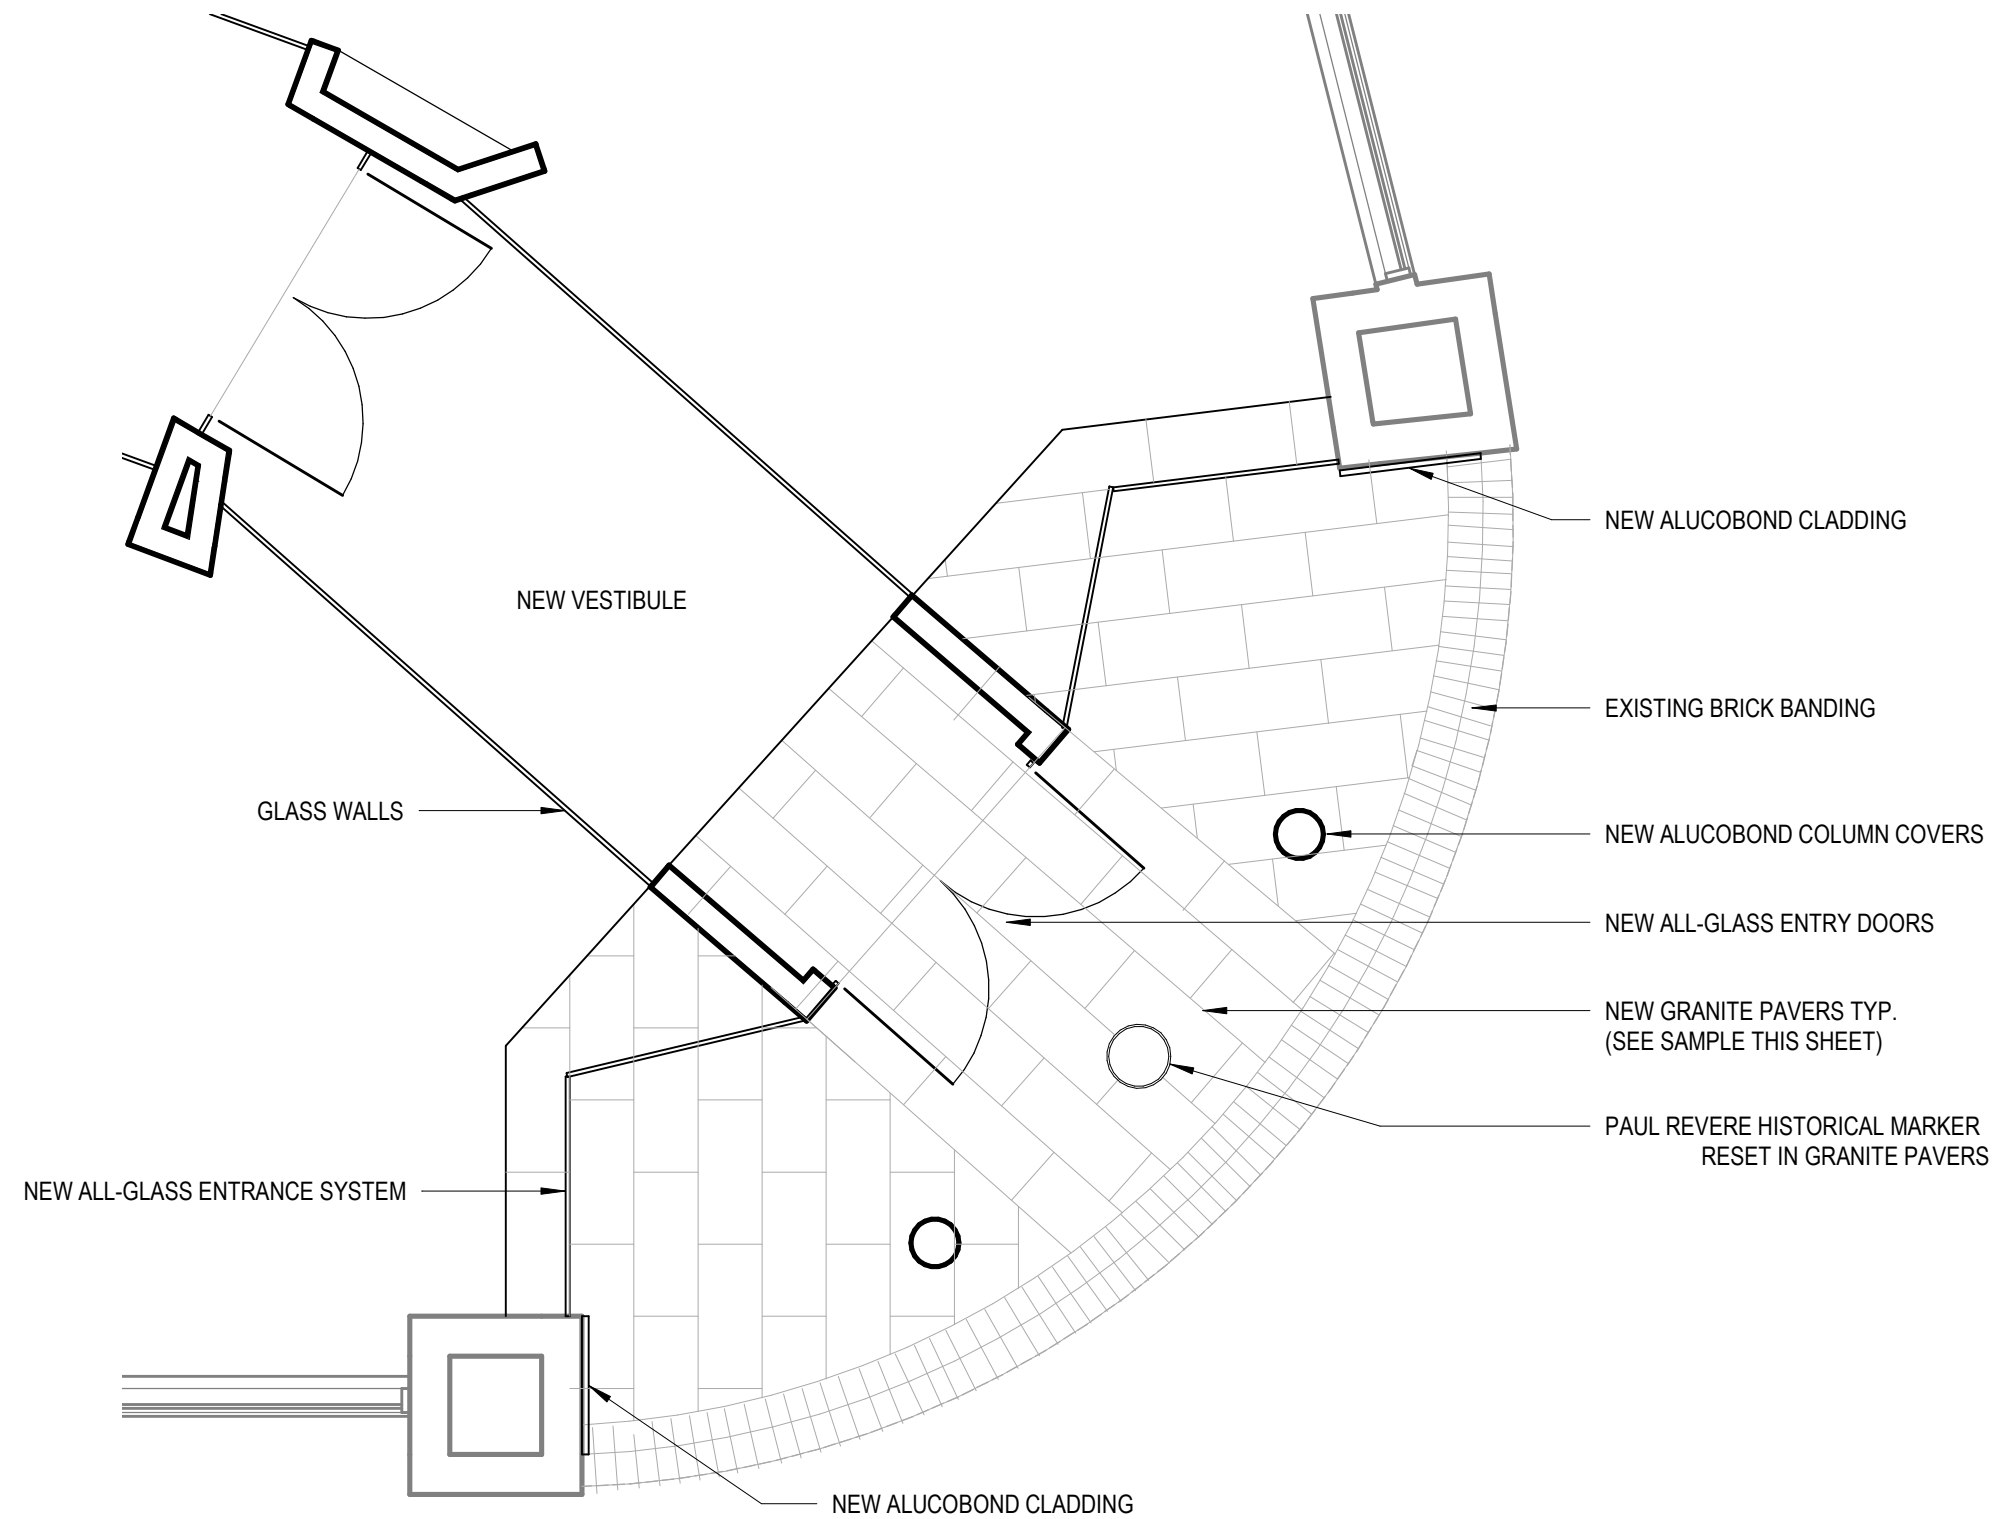

DECEMBER 16, 2020

<p>One Canal Plaza, Suite 888 Portland, Maine 04101</p> <p>207 553 2115 canal5studio.com</p>	<p>THIS DRAWING IS THE PROPERTY OF CANAL 5 STUDIO AND IS NOT TO BE COPIED OR REPRODUCED IN PART OR WHOLE. 2018 © CANAL 5 STUDIO</p>	Scale:	Project Title	REV.	DATE	DESCRIPTION	Project Status	Drawing Title	Drawing Number
		1/4" = 1'-0"	EXTERIOR RENOVATIONS				HDC APPLICATION	ENTRY FLOOR PLAN	A1
		C5S Project No. 20002							

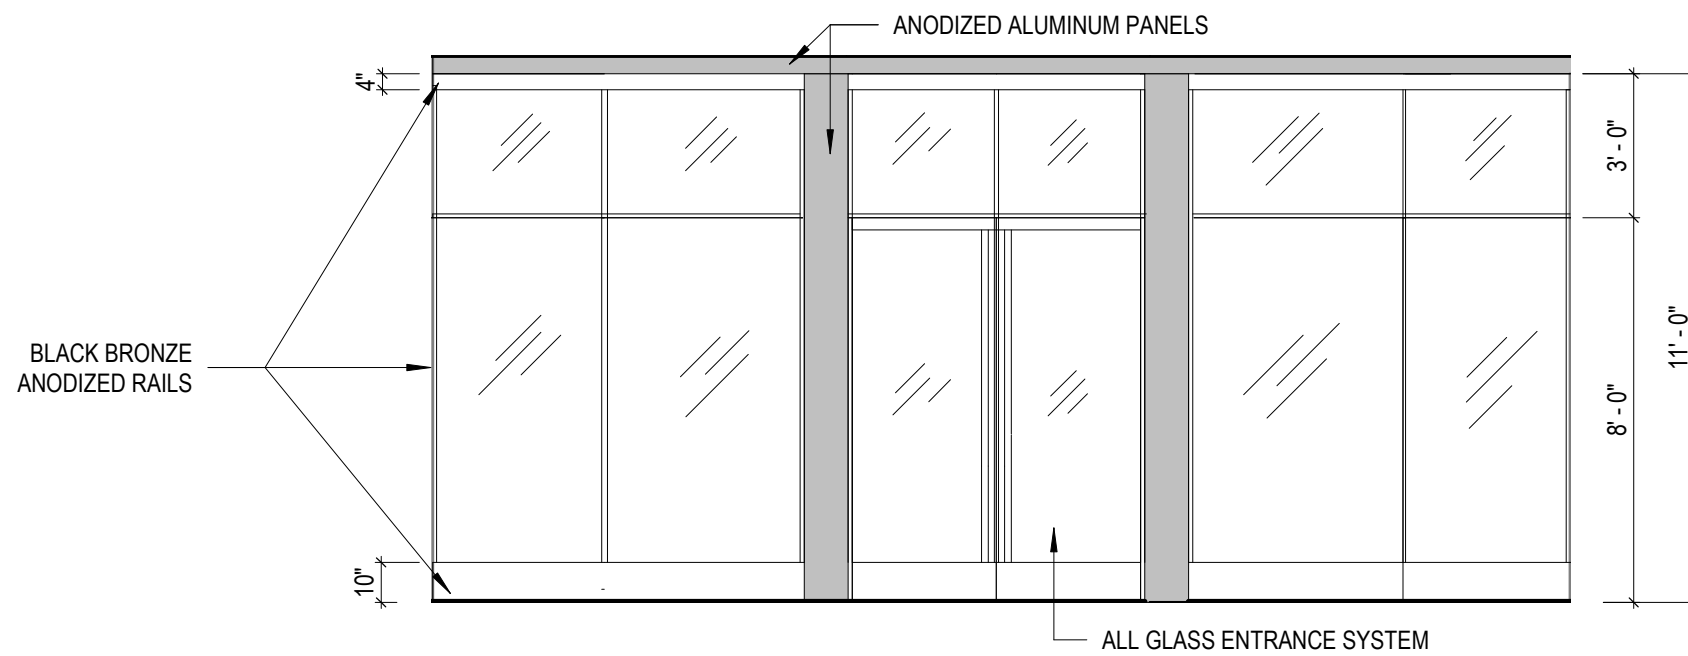


1 ENTRANCE ELEVATION
1/4" = 1'-0"



ENTRANCE SYSTEM - CR LAURENCE BLACK BRONZE ANODIZED WITH LONG "F-STYLE" HANDLES

DECEMBER 16, 2020

CANAL 5 STUDIO <small>One Canal Plaza, Suite 888 Portland, Maine 04101</small> <small>207 553 2115 canal5studio.com</small>	<small>THIS DRAWING IS THE PROPERTY OF CANAL 5 STUDIO AND IS NOT TO BE COPIED OR REPRODUCED IN PART OR WHOLE. 2018 © CANAL 5 STUDIO</small>	Scale:	Project Title	REV.	DATE	DESCRIPTION	Project Status	Drawing Title	Drawing Number
		1/4" = 1'-0"	EXTERIOR RENOVATIONS				HDC APPLICATION	ENTRANCE ELEVATION	A2
		C5S Project No. 20002							

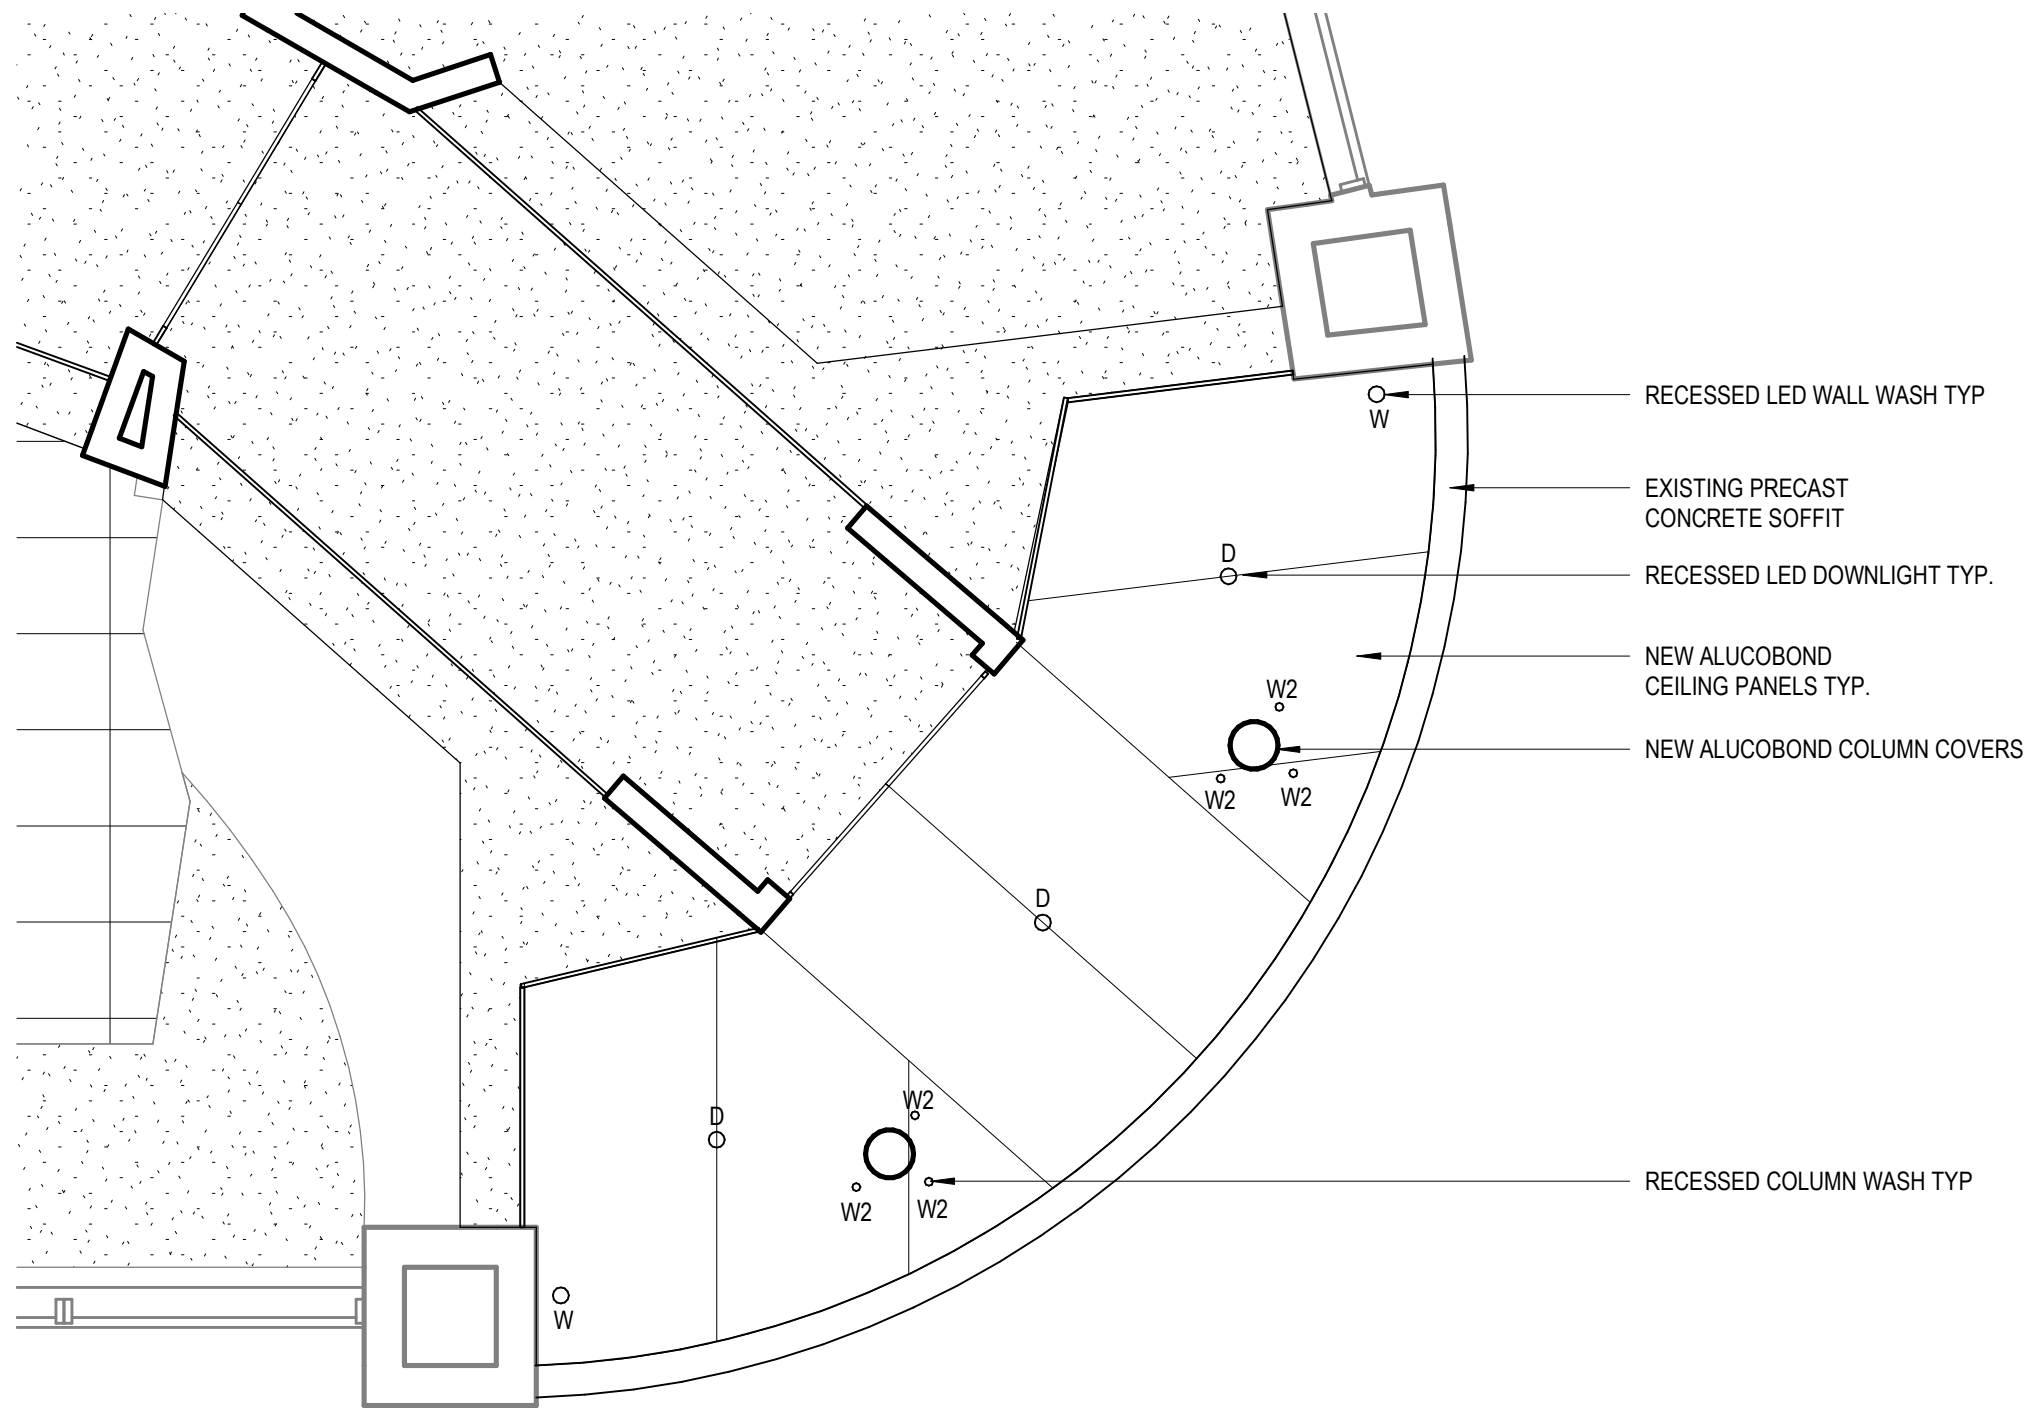


1 REFLECTED CEILING PLAN NEW
1/4" = 1'-0"

DECEMBER 16, 2020

<p>One Canal Plaza, Suite 888 Portland, Maine 04101</p> <p>207 553 2115 canal5studio.com</p>	<p>THIS DRAWING IS THE PROPERTY OF CANAL 5 STUDIO AND IS NOT TO BE COPIED OR REPRODUCED IN PART OR WHOLE. 2018 © CANAL 5 STUDIO</p>	Scale:	Project Title	REV.	DATE	DESCRIPTION	Project Status	Drawing Title	Drawing Number
		1/4" = 1'-0"	EXTERIOR RENOVATIONS				HDC APPLICATION	REFLECTED CEILING & LIGHTING PLAN	A3
		C5S Project No. 20002							



DECEMBER 16, 2020

 <p>One Canal Plaza, Suite 888 Portland, Maine 04101</p> <p>207 553 2115 canal5studio.com</p>	<p>THIS DRAWING IS THE PROPERTY OF CANAL 5 STUDIO AND IS NOT TO BE COPIED OR REPRODUCED IN PART OR WHOLE. 2018 © CANAL 5 STUDIO</p>	Scale:	Project Title	REV.	DATE	DESCRIPTION	Project Status	Drawing Title	Drawing Number
		NOT TO SCALE	EXTERIOR RENOVATIONS				HDC APPLICATION	Hanover Street Elevation	A4
		C5S Project No. 20002							

EXISTING WINDOW FRAMES & MULLIONS PAINTED BLACK TYP.



EXISTING HANOVER STREET AWNINGS TO REMAIN TYP.
PAINT METAL BLACK

NEW SIGNANGE (SEE
SPECS INCLUDED)

NEW CORNER AWNING TO
REPLACE EXISTING AWNING.
BLACK PAINTED STEEL AND GLASS

EXISTING MARKET STREET AWNINGS TO REMAIN TYP.
PAINT METAL BLACK

DECEMBER 16, 2020

CANAL 5 STUDIO

One Canal Plaza, Suite 888
Portland, Maine 04101


207 553 2115
canal5studio.com

THIS DRAWING IS
THE PROPERTY OF
CANAL 5 STUDIO AND
IS NOT TO BE COPIED
OR REPRODUCED IN
PART OR WHOLE.
2018 © CANAL 5
STUDIO

Scale:	Project Title	REV.	DATE	DESCRIPTION	Project Status	Drawing Title	Drawing Number
NOT TO SCALE	EXTERIOR RENOVATIONS				HDC APPLICATION	Corner Elevation	A5
C5S Project No.							
20002							




DECEMBER 16, 2020

 <p>One Canal Plaza, Suite 888 Portland, Maine 04101</p> <p>207 553 2115 canal5studio.com</p>	<p>THIS DRAWING IS THE PROPERTY OF CANAL 5 STUDIO AND IS NOT TO BE COPIED OR REPRODUCED IN PART OR WHOLE. 2018 © CANAL 5 STUDIO</p>	Scale:	Project Title	REV.	DATE	DESCRIPTION	Project Status	Drawing Title	Drawing Number
		NOT TO SCALE	EXTERIOR RENOVATIONS				HDC APPLICATION	Market Street Elevation	A6
		C5S Project No. 20002							



DECEMBER 16, 2020

 <p>One Canal Plaza, Suite 888 Portland, Maine 04101</p> <p>207 553 2115 canal5studio.com</p>	<p>THIS DRAWING IS THE PROPERTY OF CANAL 5 STUDIO AND IS NOT TO BE COPIED OR REPRODUCED IN PART OR WHOLE. 2018 © CANAL 5 STUDIO</p>	Scale:	Project Title	REV.	DATE	DESCRIPTION	Project Status	Drawing Title	Drawing Number
		NOT TO SCALE	EXTERIOR RENOVATIONS				HDC APPLICATION	CORNER PERSPECTIVE	A7
		C5S Project No. 20002							